



SITE FURNISHINGS SCHEDULE PARK SOUTH

SYMBOL	DESCRIPTION	QTY
S-101	COB STANDARD FOLD DOWN BOLLARD PER DRAWING #02840.01	1
S-108	TRASH RECEPTACLE, COB PARK STANDARD	1
S-110	PICNIC TABLE W/ CONC. PAD, COB PARK STANDARD	1

PAVING SCHEDULE PARK SOUTH

SYMBOL	CONCRETE DESCRIPTION	QTY
P-101	CRUSHED LIMESTONE PATH - SEE CIVIL	2,925 sf

4			
3			
2			
1			
Date	No	Revision	By

PROJECT ENGINEER _____
 DESIGNED/DRAWN _____
 INSPECTOR _____

DIRECTOR PUBLIC WORKS E.C.J.
 CITY ENGINEER C.M.A.S.
 ASSISTANT DIRECTOR M.A.O.

CITY OF BELLINGHAM, WASHINGTON
 PUBLIC WORKS DEPARTMENT
 ENGINEERING DIVISION


SCALE
 Horiz. 1"=20'
 Vert. _____

DATUM
 NAD 83/98
 NAVD 88

Job. No. _____
 Date _____
 Field Bk. _____

STORYBROOK PARK - PHASE 1
LANDSCAPE REFERENCE PLAN - L1.0

SHEET
6 OF
13

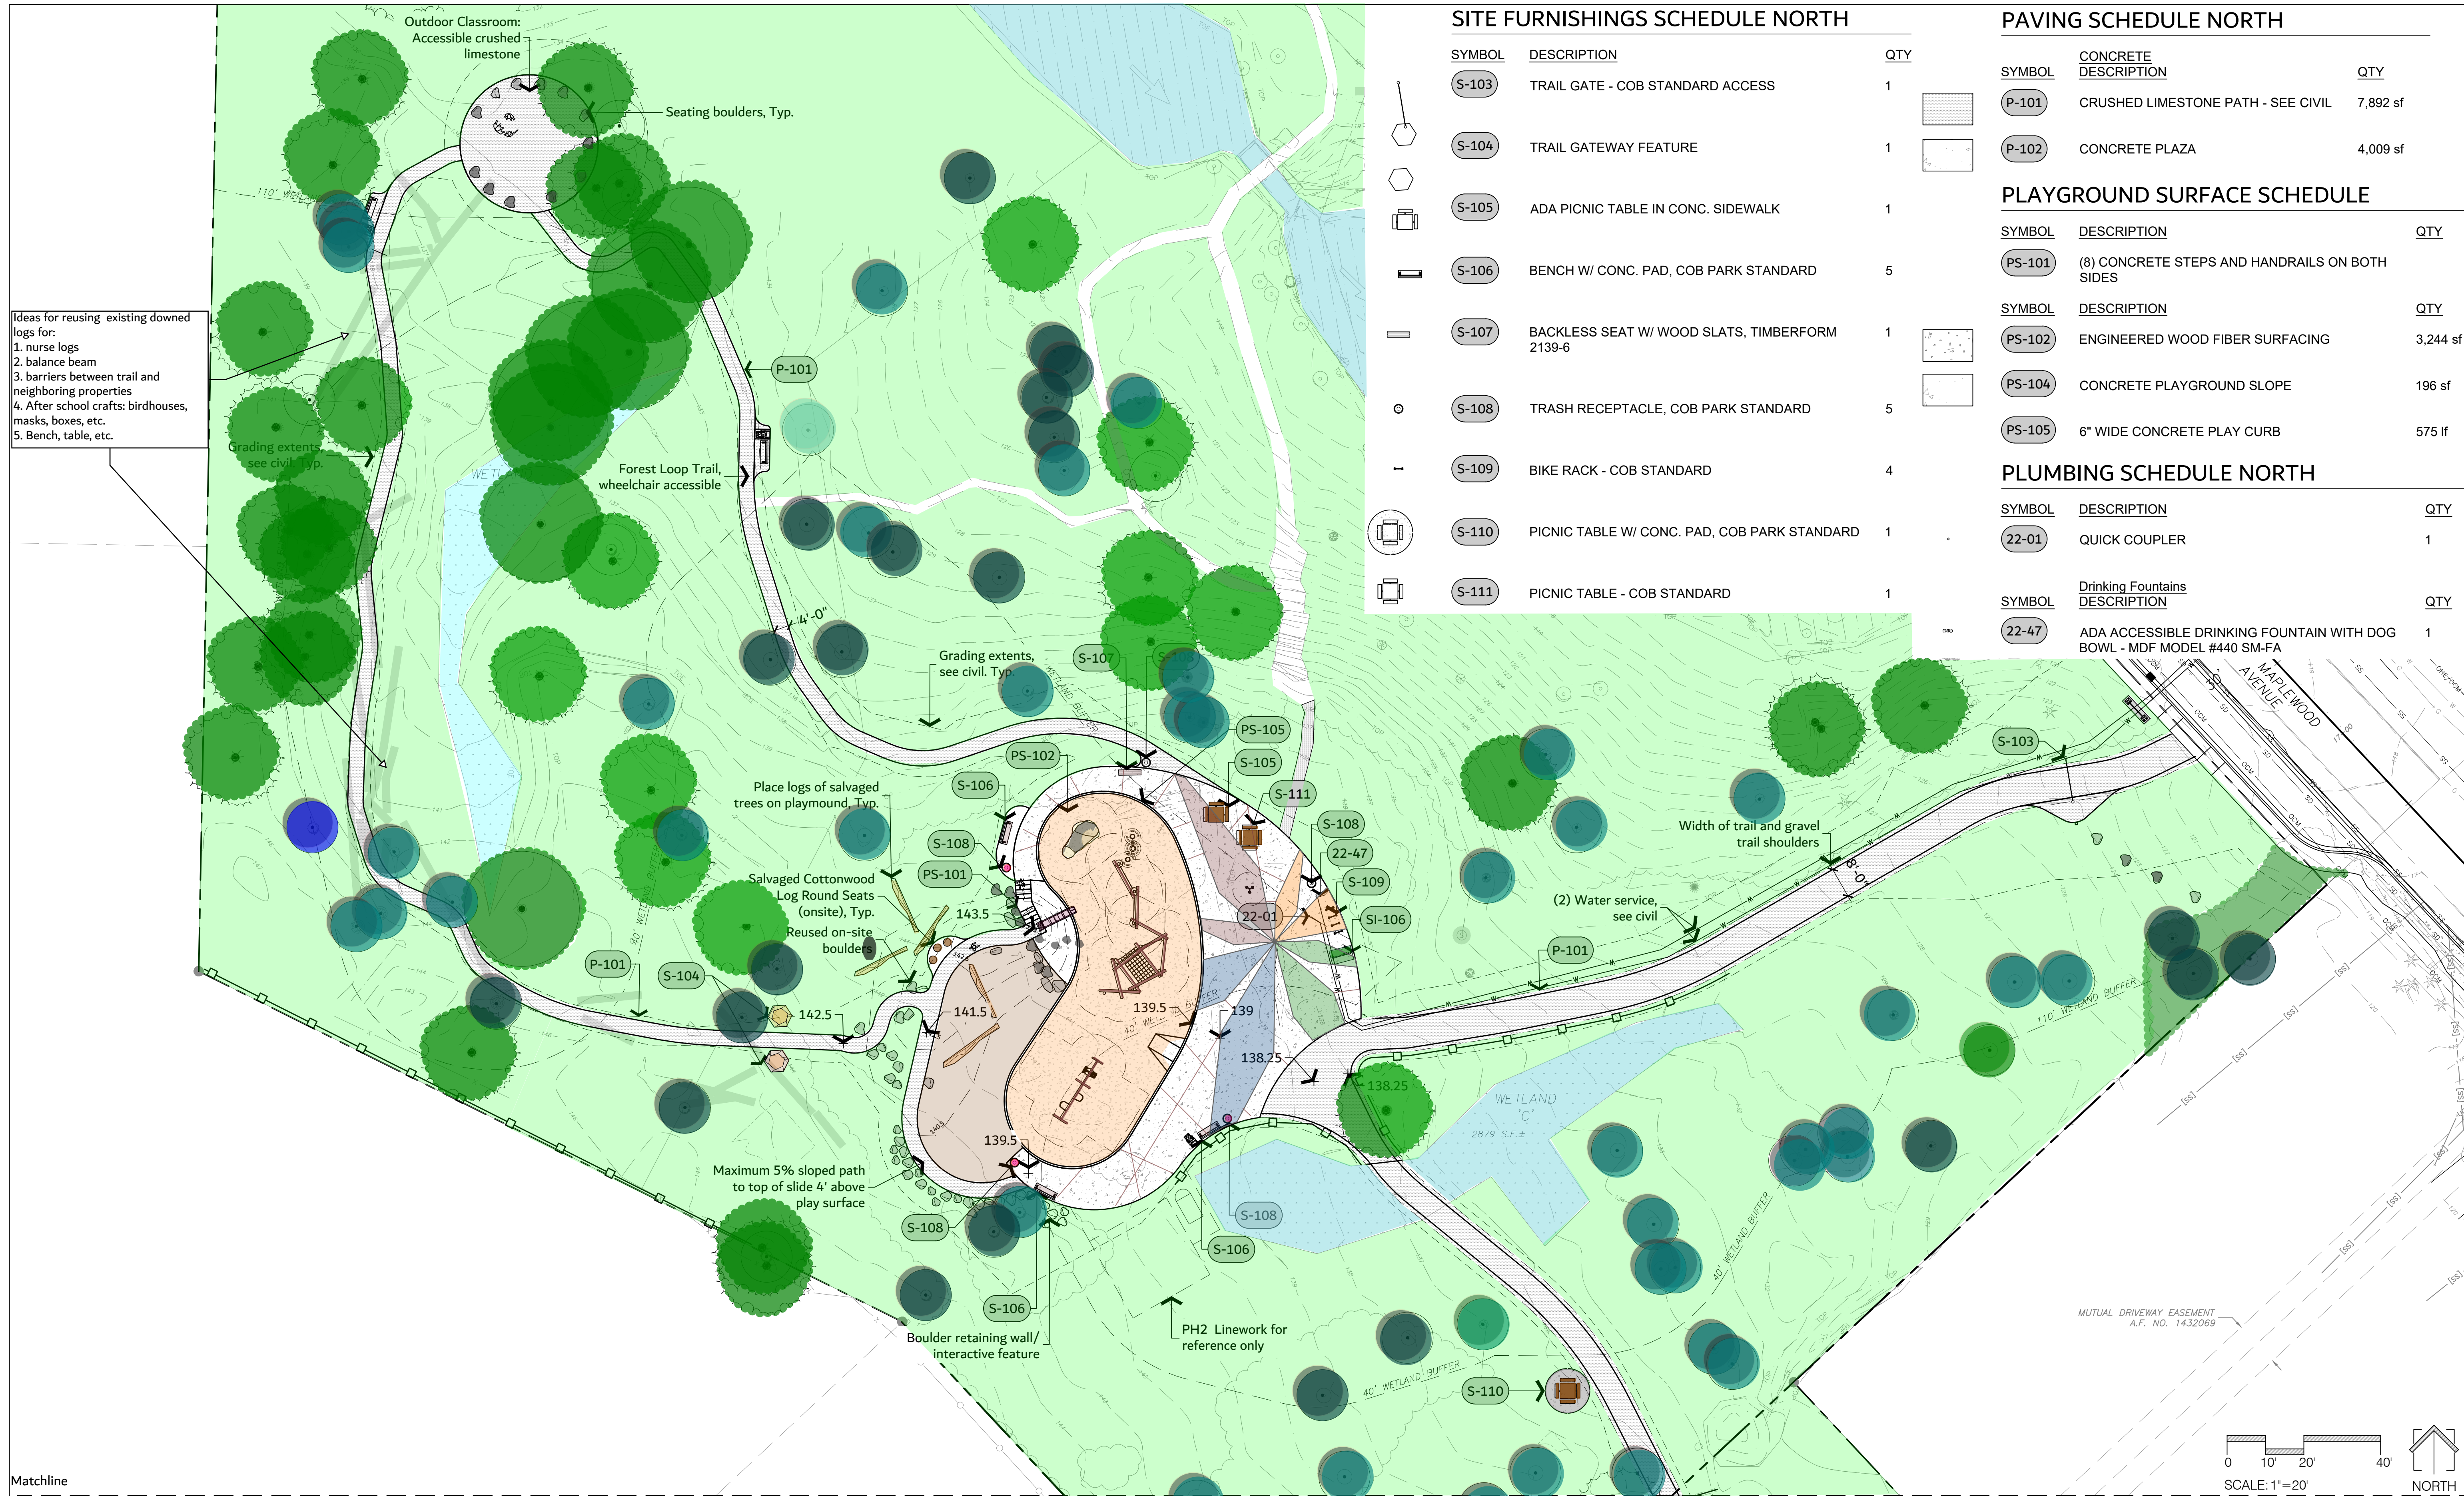

Ideas for reusing existing downed logs for:

- nurse logs
- balance beam
- barriers between trail and neighboring properties
- After school crafts: birdhouses, masks, boxes, etc.
- Bench, table, etc.

SITE FURNISHINGS SCHEDULE NORTH

SYMBOL	DESCRIPTION	QTY
	S-103 TRAIL GATE - COB STANDARD ACCESS	1
	S-104 TRAIL GATEWAY FEATURE	1
	S-105 ADA PICNIC TABLE IN CONC. SIDEWALK	1
	S-106 BENCH W/ CONC. PAD, COB PARK STANDARD	5
	S-107 BACKLESS SEAT W/ WOOD SLATS, TIMBERFORM 2139-6	1
	S-108 TRASH RECEPTACLE, COB PARK STANDARD	5
	S-109 BIKE RACK - COB STANDARD	4
	S-110 PICNIC TABLE W/ CONC. PAD, COB PARK STANDARD	1
	S-111 PICNIC TABLE - COB STANDARD	1

PAVING SCHEDULE NORTH

SYMBOL	CONCRETE DESCRIPTION	QTY
	P-101 CRUSHED LIMESTONE PATH - SEE CIVIL	7,892 sf
	P-102 CONCRETE PLAZA	4,009 sf

PLAYGROUND SURFACE SCHEDULE

SYMBOL	DESCRIPTION	QTY
	PS-101 (8) CONCRETE STEPS AND HANDRAILS ON BOTH SIDES	
	PS-102 ENGINEERED WOOD FIBER SURFACING	3,244 sf
	PS-104 CONCRETE PLAYGROUND SLOPE	196 sf
	PS-105 6" WIDE CONCRETE PLAY CURB	575 lf

PLUMBING SCHEDULE NORTH

SYMBOL	DESCRIPTION	QTY
	22-01 QUICK COUPLER	1
	22-47 ADA ACCESSIBLE DRINKING FOUNTAIN WITH DOG BOWL - MDF MODEL #440 SM-FA	1

Date	No	Revision	By
	4		
	3		
	2		
	1		

PROJECT ENGINEER _____
 DESIGNED/DRAWN _____
 INSPECTOR _____

DIRECTOR PUBLIC WORKS E.C.J.
 CITY ENGINEER C.M.A.S.
 ASSISTANT DIRECTOR M.A.O.

CITY OF BELLINGHAM, WASHINGTON
PUBLIC WORKS DEPARTMENT
 ENGINEERING DIVISION

SCALE
 Horiz. 1"=20'
 Vert. 1"


DATUM
 NAD 83/98
 NAVD 88

Job. No. _____
 Date _____
 Field Bk. _____


STORYBROOK PARK - PHASE 1
LANDSCAPE REFERENCE PLAN - L1.1

SHEET
7 OF
13



PLOT SETTINGS: WE AutoCAD PDF (General Documentation).pc3; WILSON 22x34; Portrait; 1:1; WE APWA_SCREENED.ctb
 W:\2022\2022-108 COB STORYBROOK (MAPLEWOOD-MCLEOD) PARK\DWG\02 PARK FRONTAGE DWGS\2021_2022-108_SET 2_C2.1 FRONTAGE IMPROVEMENTS.DWG - 3/24/2023 10:52 AM - Jeff Smith

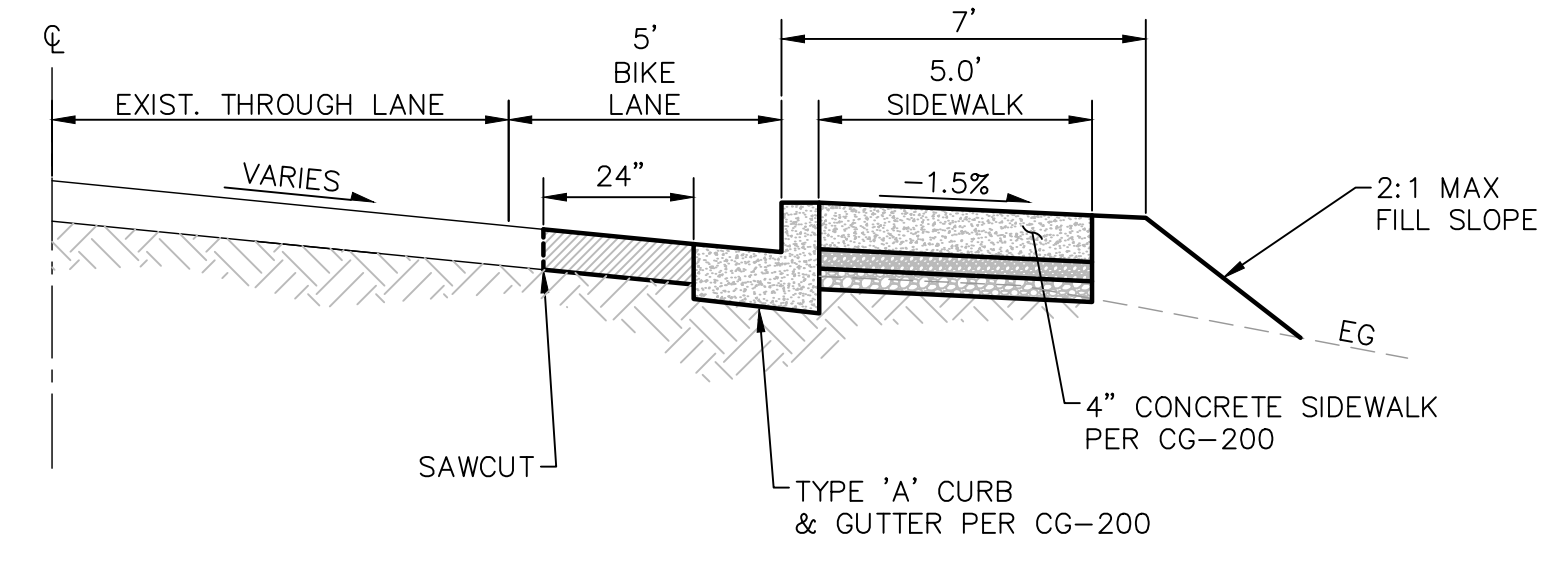



TYPICAL SECTION 'A'
NOT TO SCALE

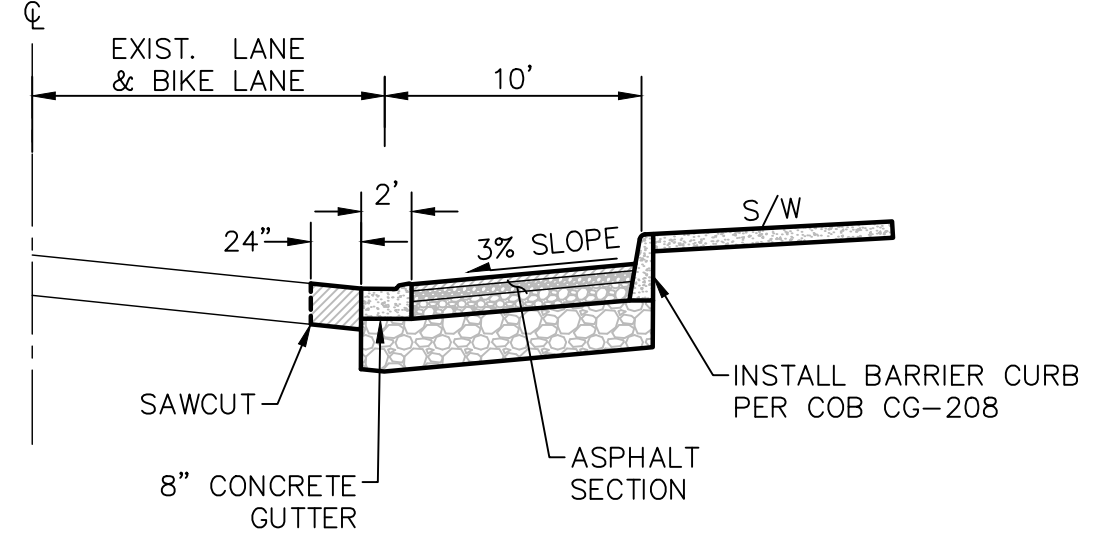

TYPICAL SECTION 'B'
NOT TO SCALE

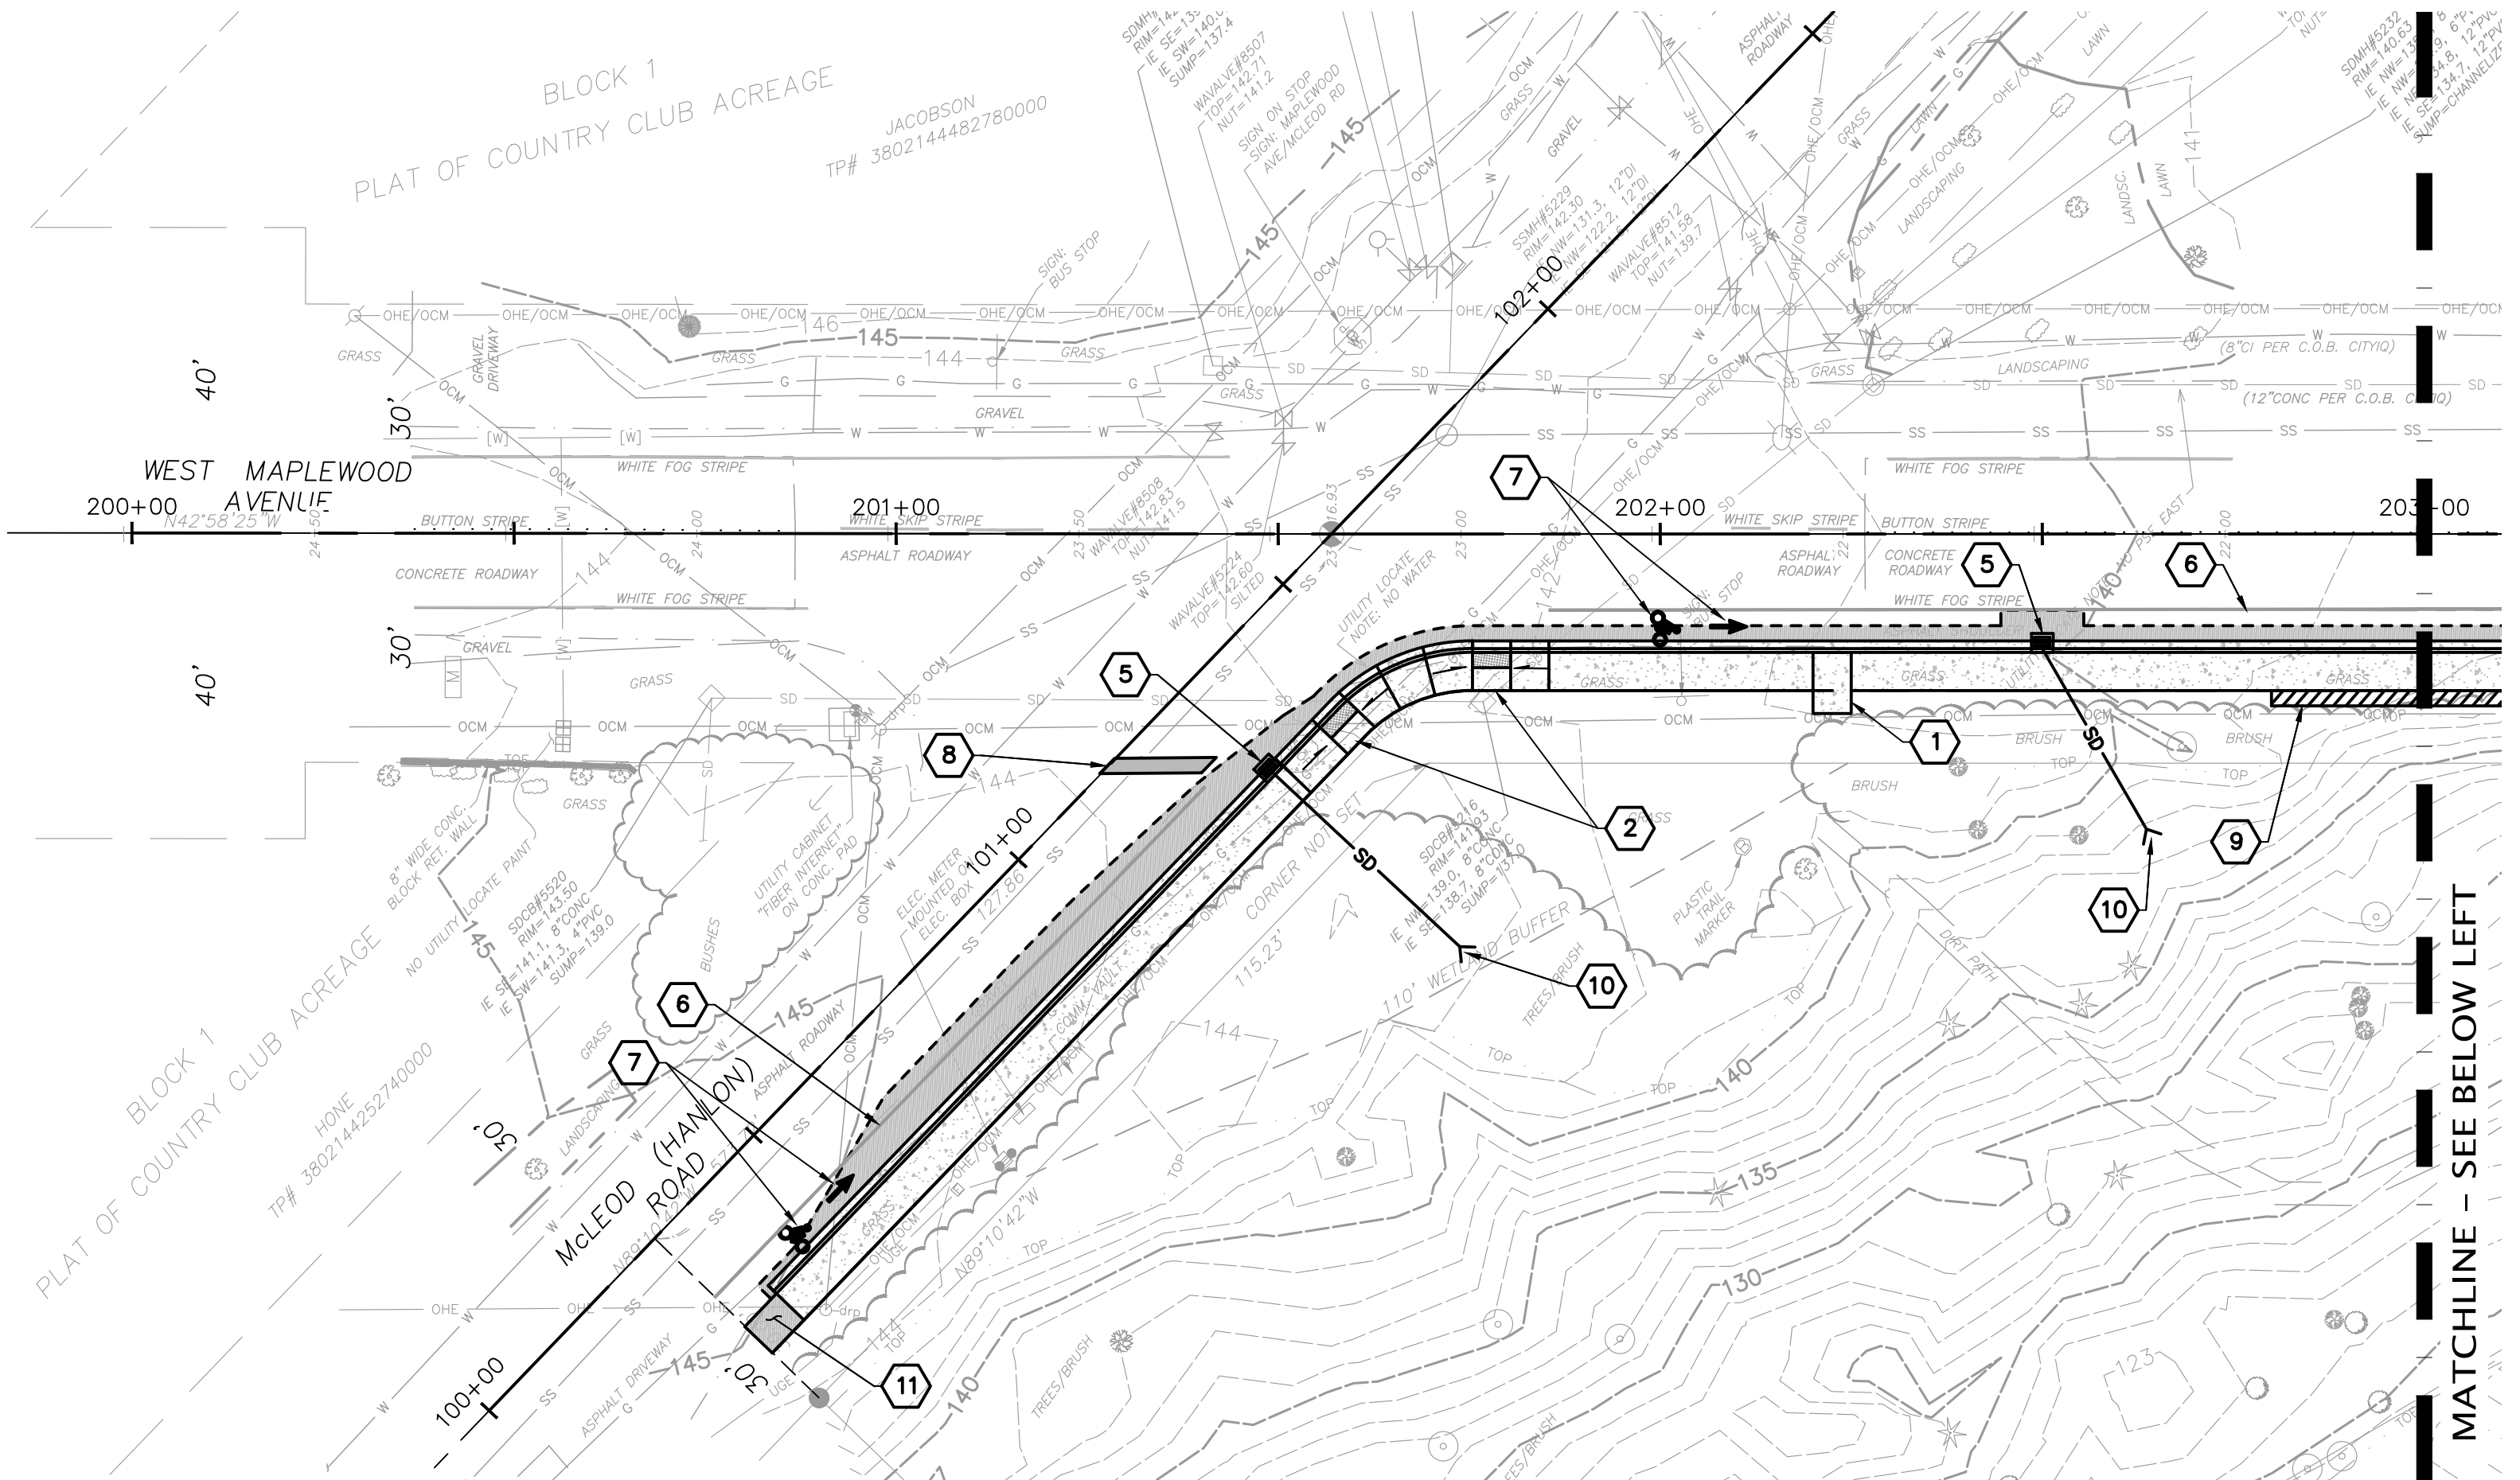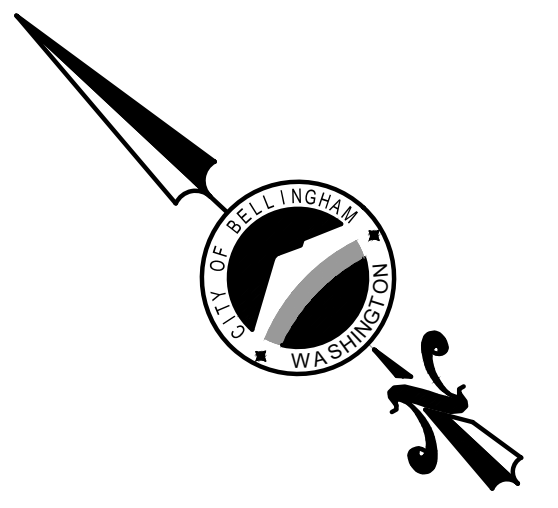


- KEYED NOTES**
- ① = ADA BUS STOP
 - ② = PROPOSED PARALLEL CURB RAMP PER WSDOT F-40.12-03
 - ③ = TIE IN TO EXISTING STORM DRAIN
 - ④ = CAST WALL AROUND BOX CULVERT
 - ⑤ = CATCH BASIN TYPE 1
 - ⑥ = 6" SOLID WHITE PLASTIC STRIPE PER TC-315
 - ⑦ = BICYCLE LANE SYMBOL PER TC-315
 - ⑧ = WHITE PLASTIC STOP BAR
 - ⑨ = CONCRETE RETAINING WALL WITH HANDRAIL STA 202+80 TO STA 203+65 H=2' TO 4' STA 204+40 TO STA 206+95 H=2' TO 6'
 - ⑩ = DISPERSION OUTFALL TO MAINTAIN WETLAND HYDROLOGY
 - ⑪ = 6" ASPHALT RAMP AT END OF SIDEWALK PER CG-230
 - ⑫ = RELOCATE MAILBOX AND WIDEN SIDEWALK TO MAINTAIN 5-FT OF UNOBSTRUCTED WIDTH PER MS-1050
 - ⑬ = TYPE 2 CONCRETE DRIVEWAY PER CG-260
 - ⑭ = SEE STORYBROOK PARK PLAN SET FOR MAPLEWOOD TRAIL ALIGNMENT AND GRADES

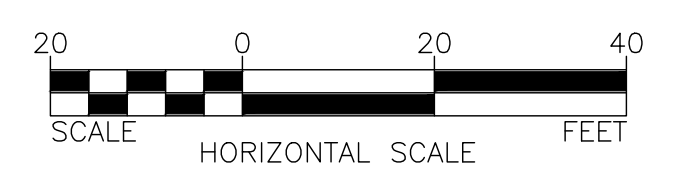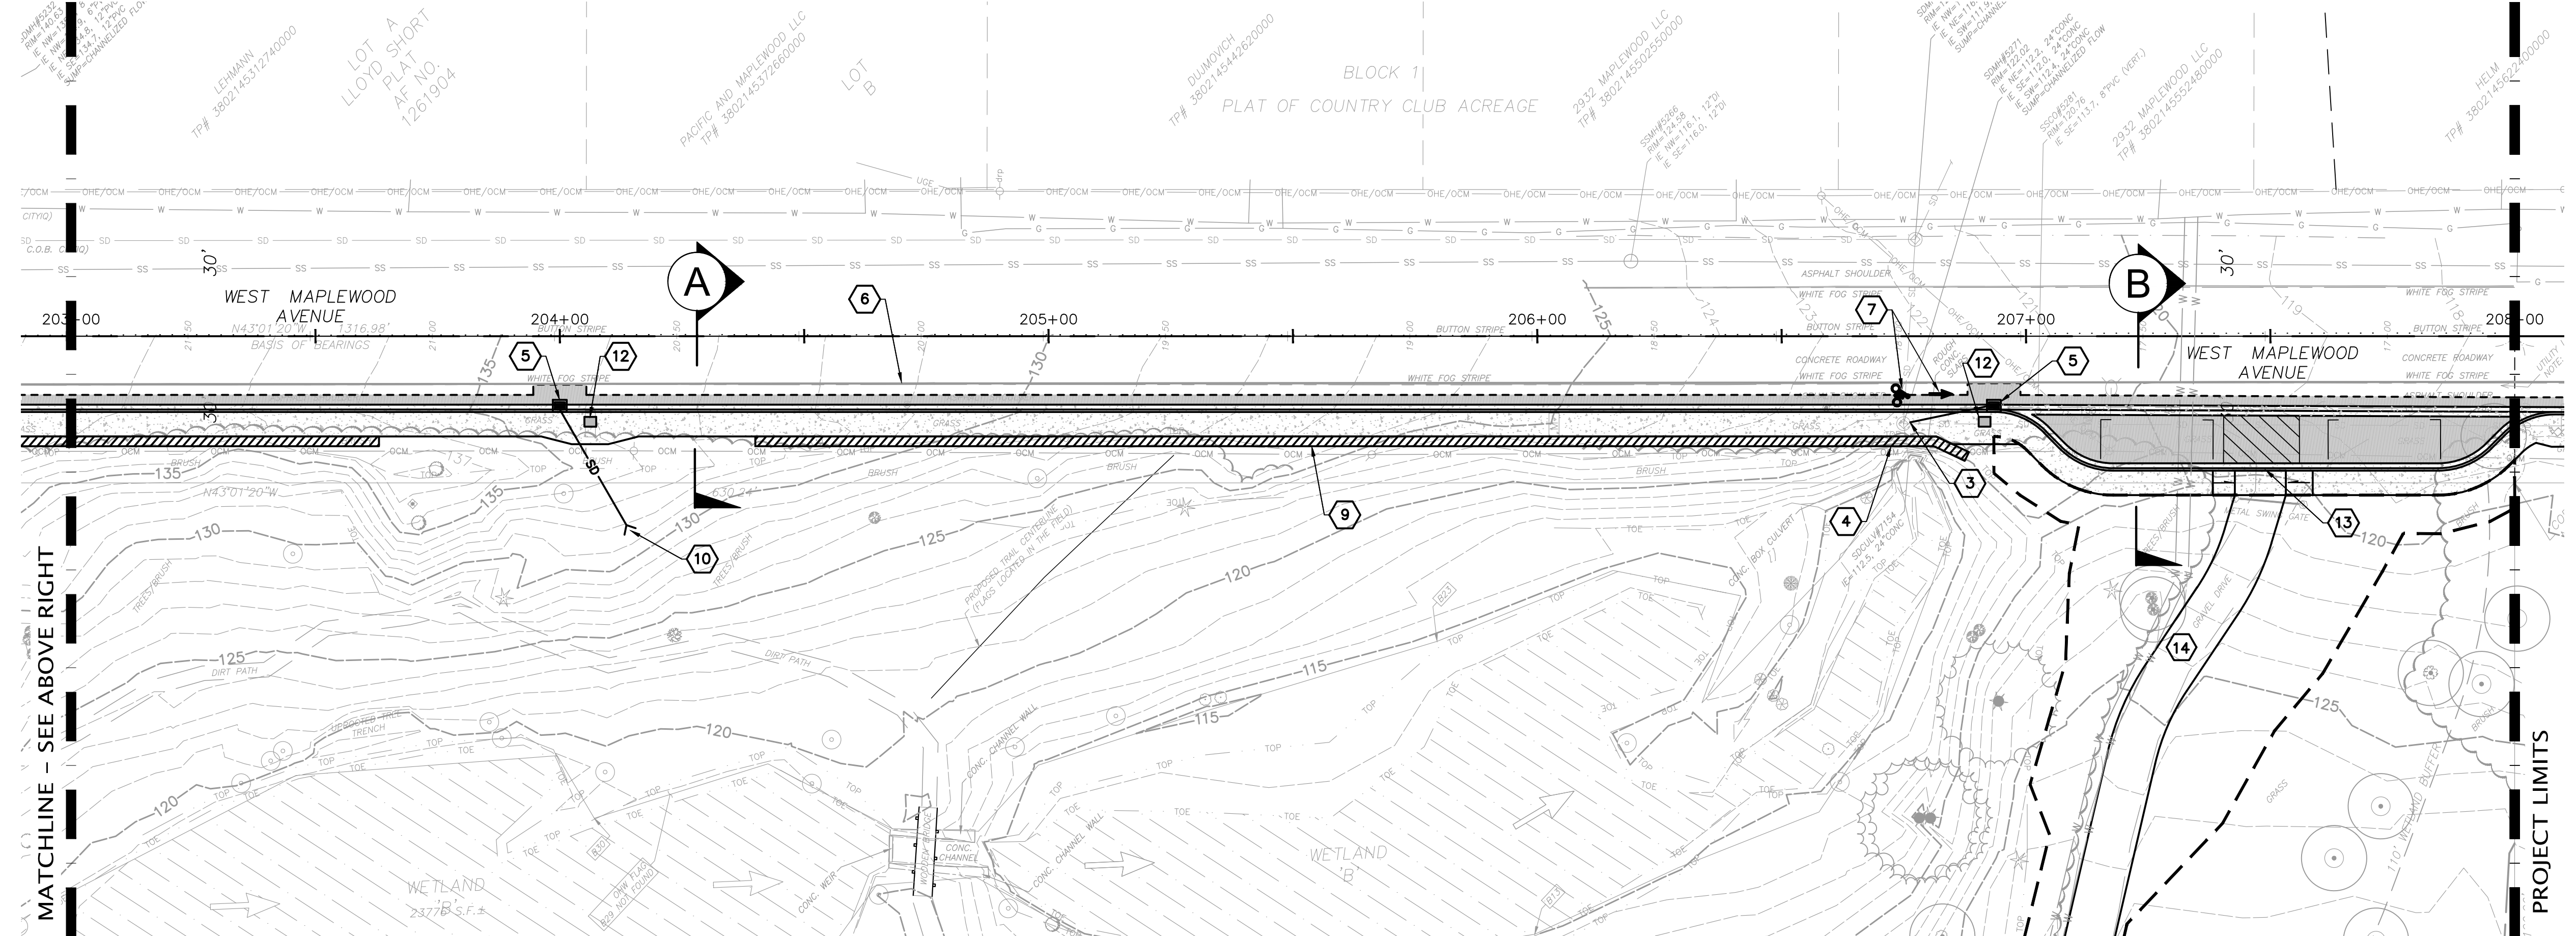

811 Call 811
two business days before you dig

30% DESIGN

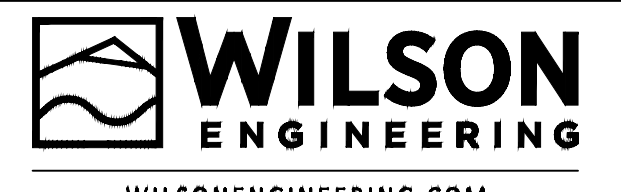

Date	No	Revision	By
	4		
	3		
	2		
	1		

PROJECT ENGINEER DJ
 DESIGNED/DRAWN PMT/JGS
 INSPECTOR XXX

DIRECTOR PUBLIC WORKS ECJ
 CITY ENGINEER --
 ASSISTANT DIRECTOR --

CITY OF BELLINGHAM, WASHINGTON
 PUBLIC WORKS DEPARTMENT
 ENGINEERING DIVISION

SCALE
 Horiz. As Shown
 Vert. As Shown

DATUM
 H: NAD 83/98
 V: NAVD 88


Job. No. --
 Date 3/24/2023
 Field Bk.

STORYBROOK PARK FRONTAGE
 PARK FRONTAGE SITE PLAN

DRAWING NO. C2.1
 SHEET NO. 6 OF 6



CONTACT PERSON: _____

PROJECT LIMITS
190.00'

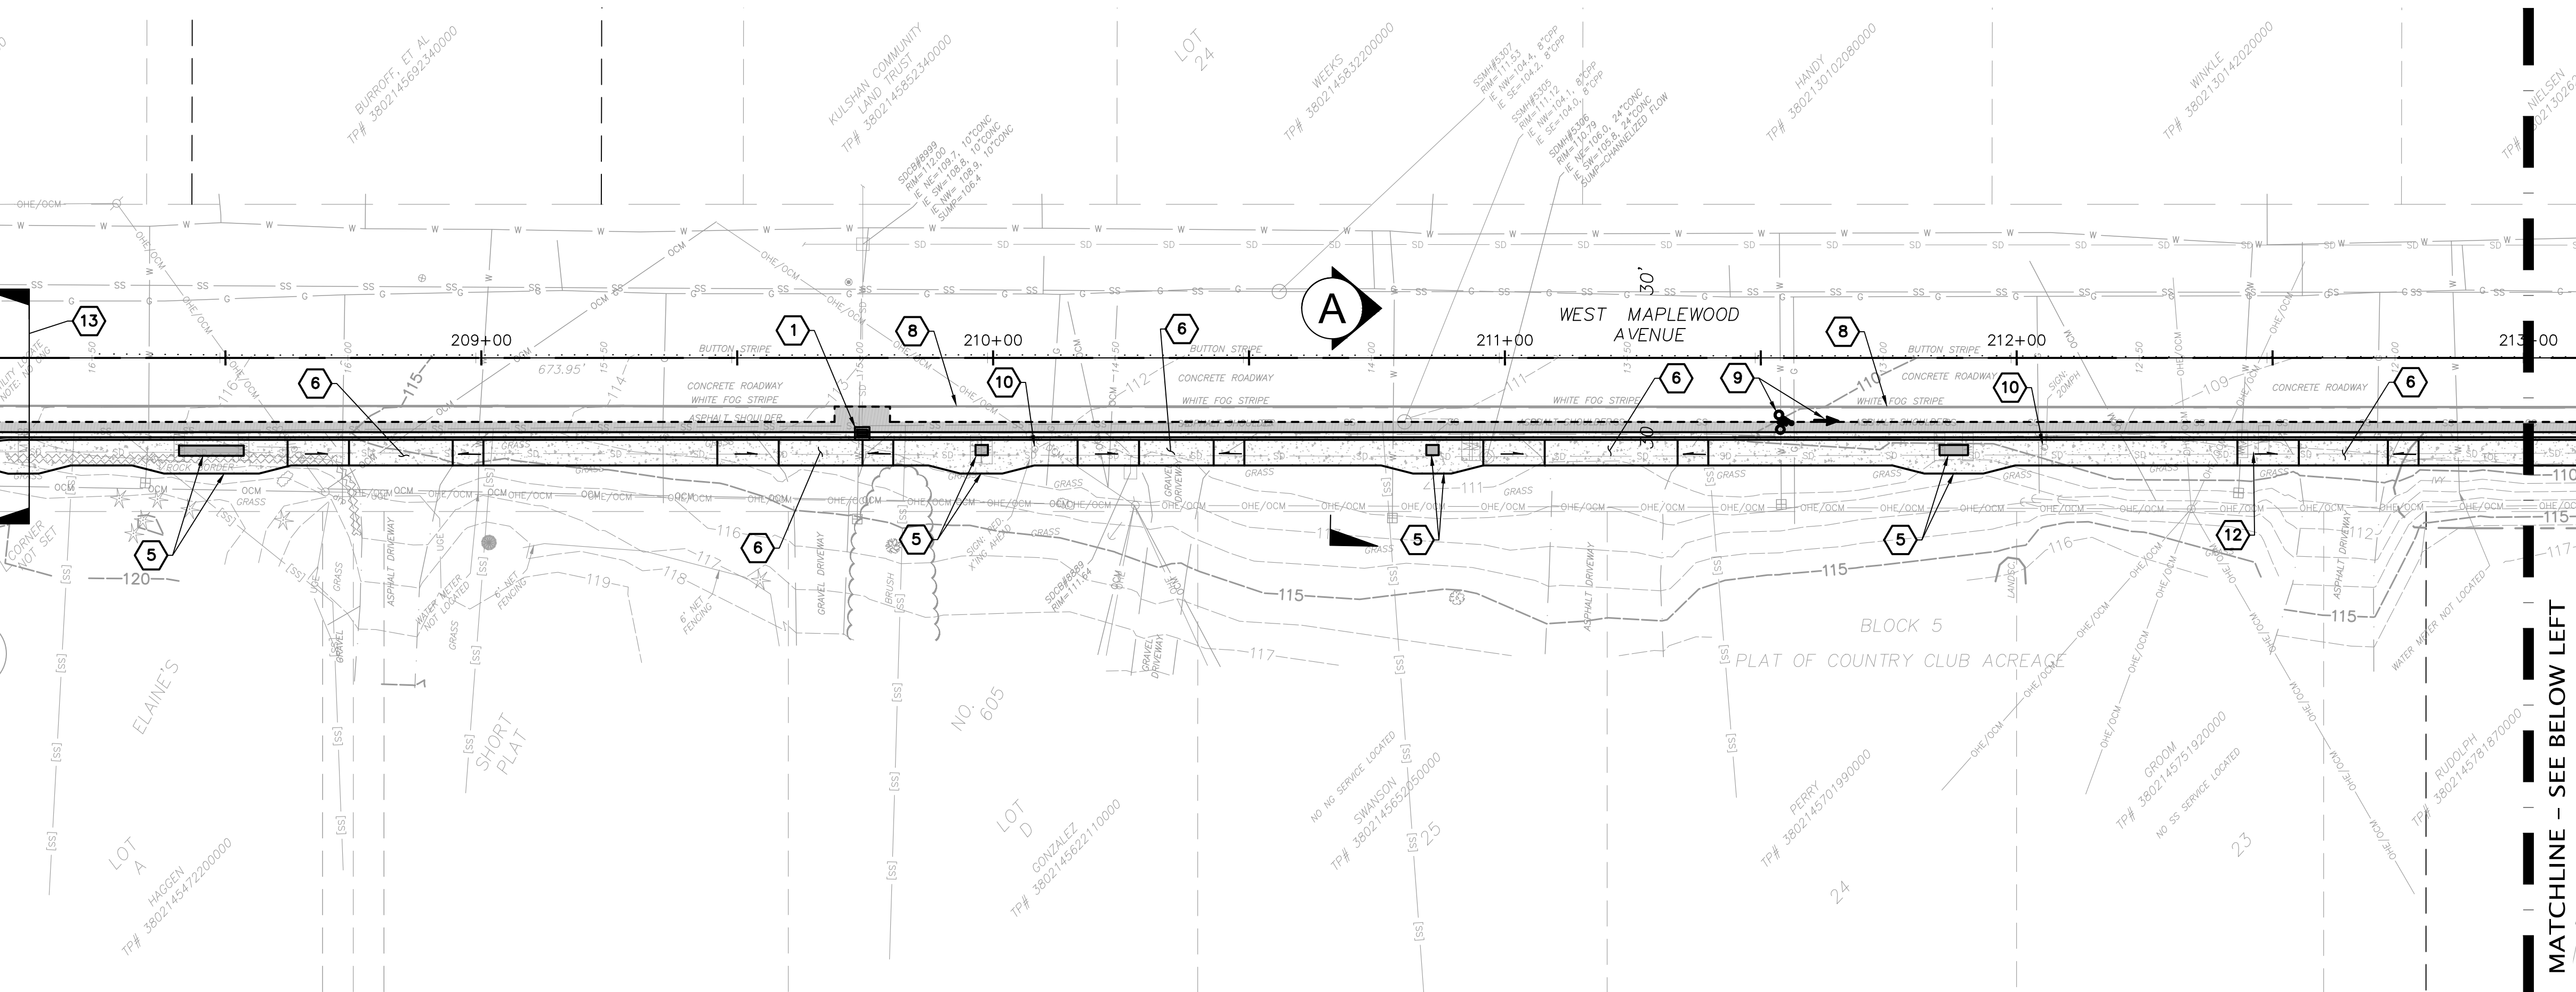

- KEYED NOTES**
- 1 = CATCH BASIN TYPE 1 PER $\begin{matrix} X \\ XXX \end{matrix}$
 - 2 = PROPOSED PARALLEL CURB RAMP PER WSDOT F-40.12-03
 - 3 = RELOCATE EX. SDCB TO FLOW LINE
 - 4 = ASPHALT TIE-IN
 - 5 = RELOCATE MAILBOX AND WIDEN SIDEWALK TO MAINTAIN 5 FT OF UNOBSTRUCTED WIDTH PER MS-1050
 - 6 = TYPE 2 CONCRETE DRIVEWAY PER CG-260
 - 7 = ADDITIONAL RIGHT-OF-WAY REQUIRED
 - 8 = 6" SOLID WHITE PLASTIC STRIPE PER TC-315
 - 9 = BICYCLE LANE SYMBOL PER TC-315
 - 10 = RELOCATE SIGN
 - 11 = CROSSWALK BARS PER TC-310
 - 12 = MAILBOX TO BE REMOVED
 - 13 = STA 208+00: MATCH ADJACENT SIDEWALK IMPROVEMENTS


MATCHLINE - SEE BELOW LEFT

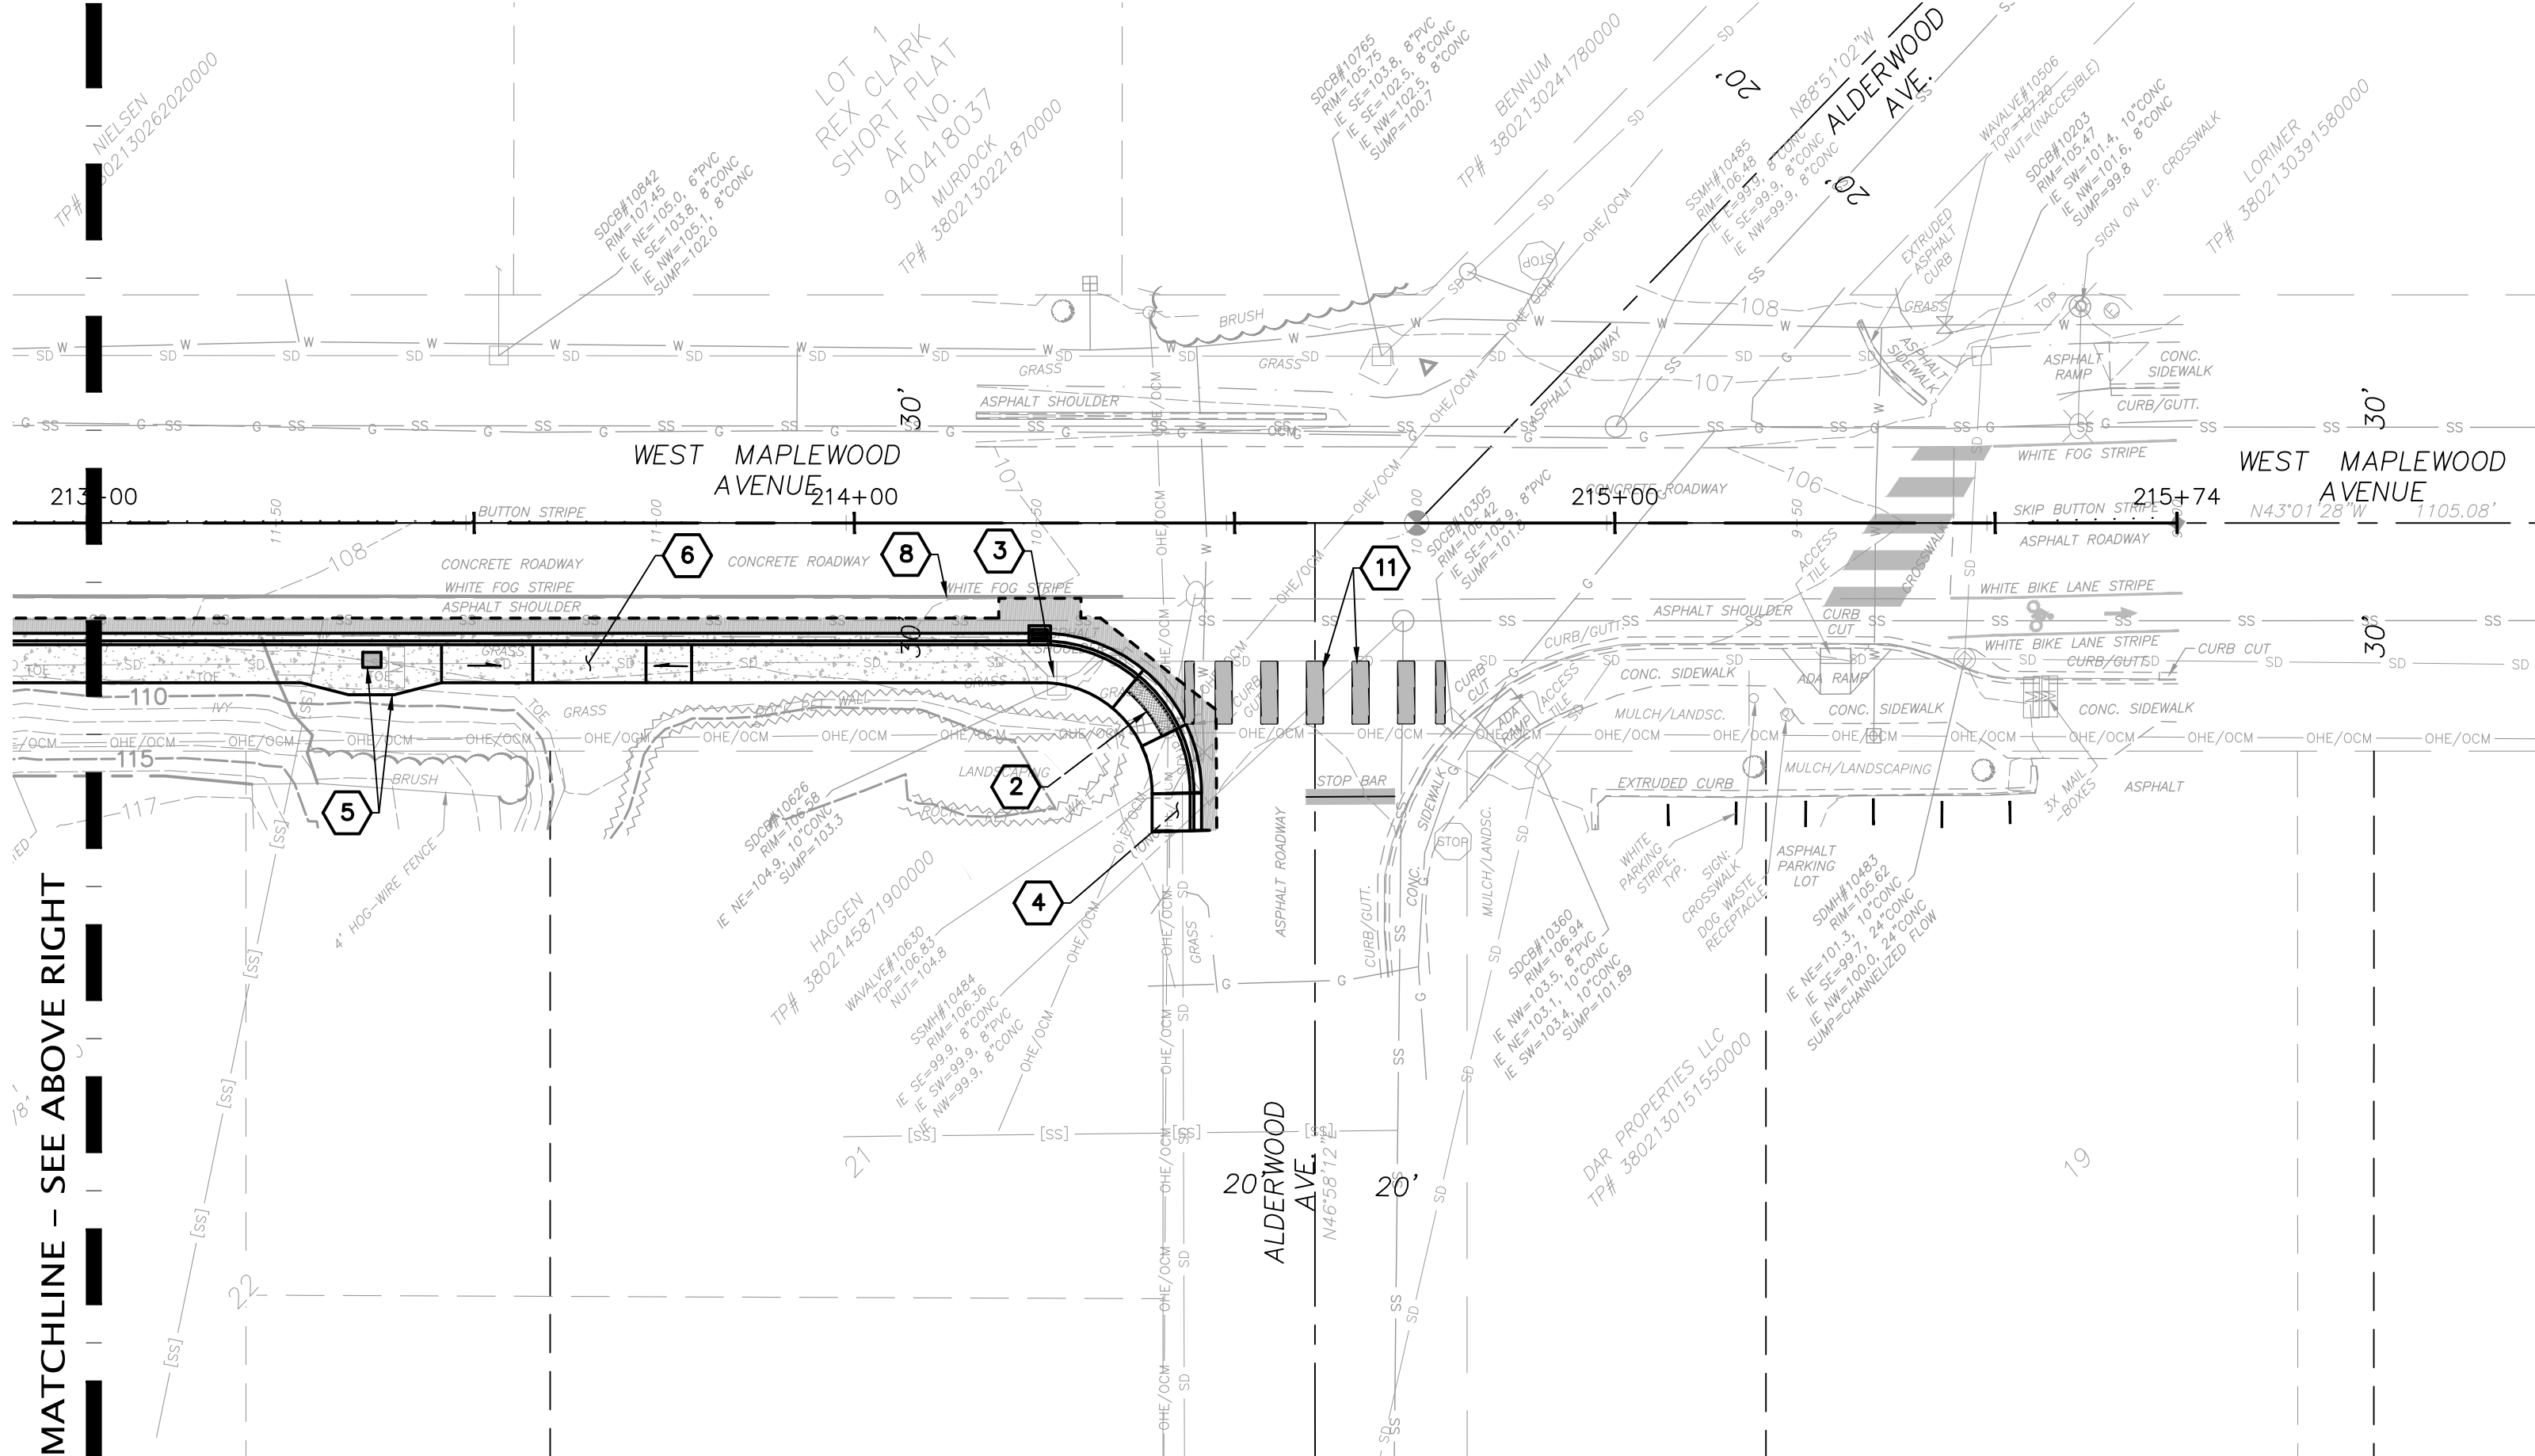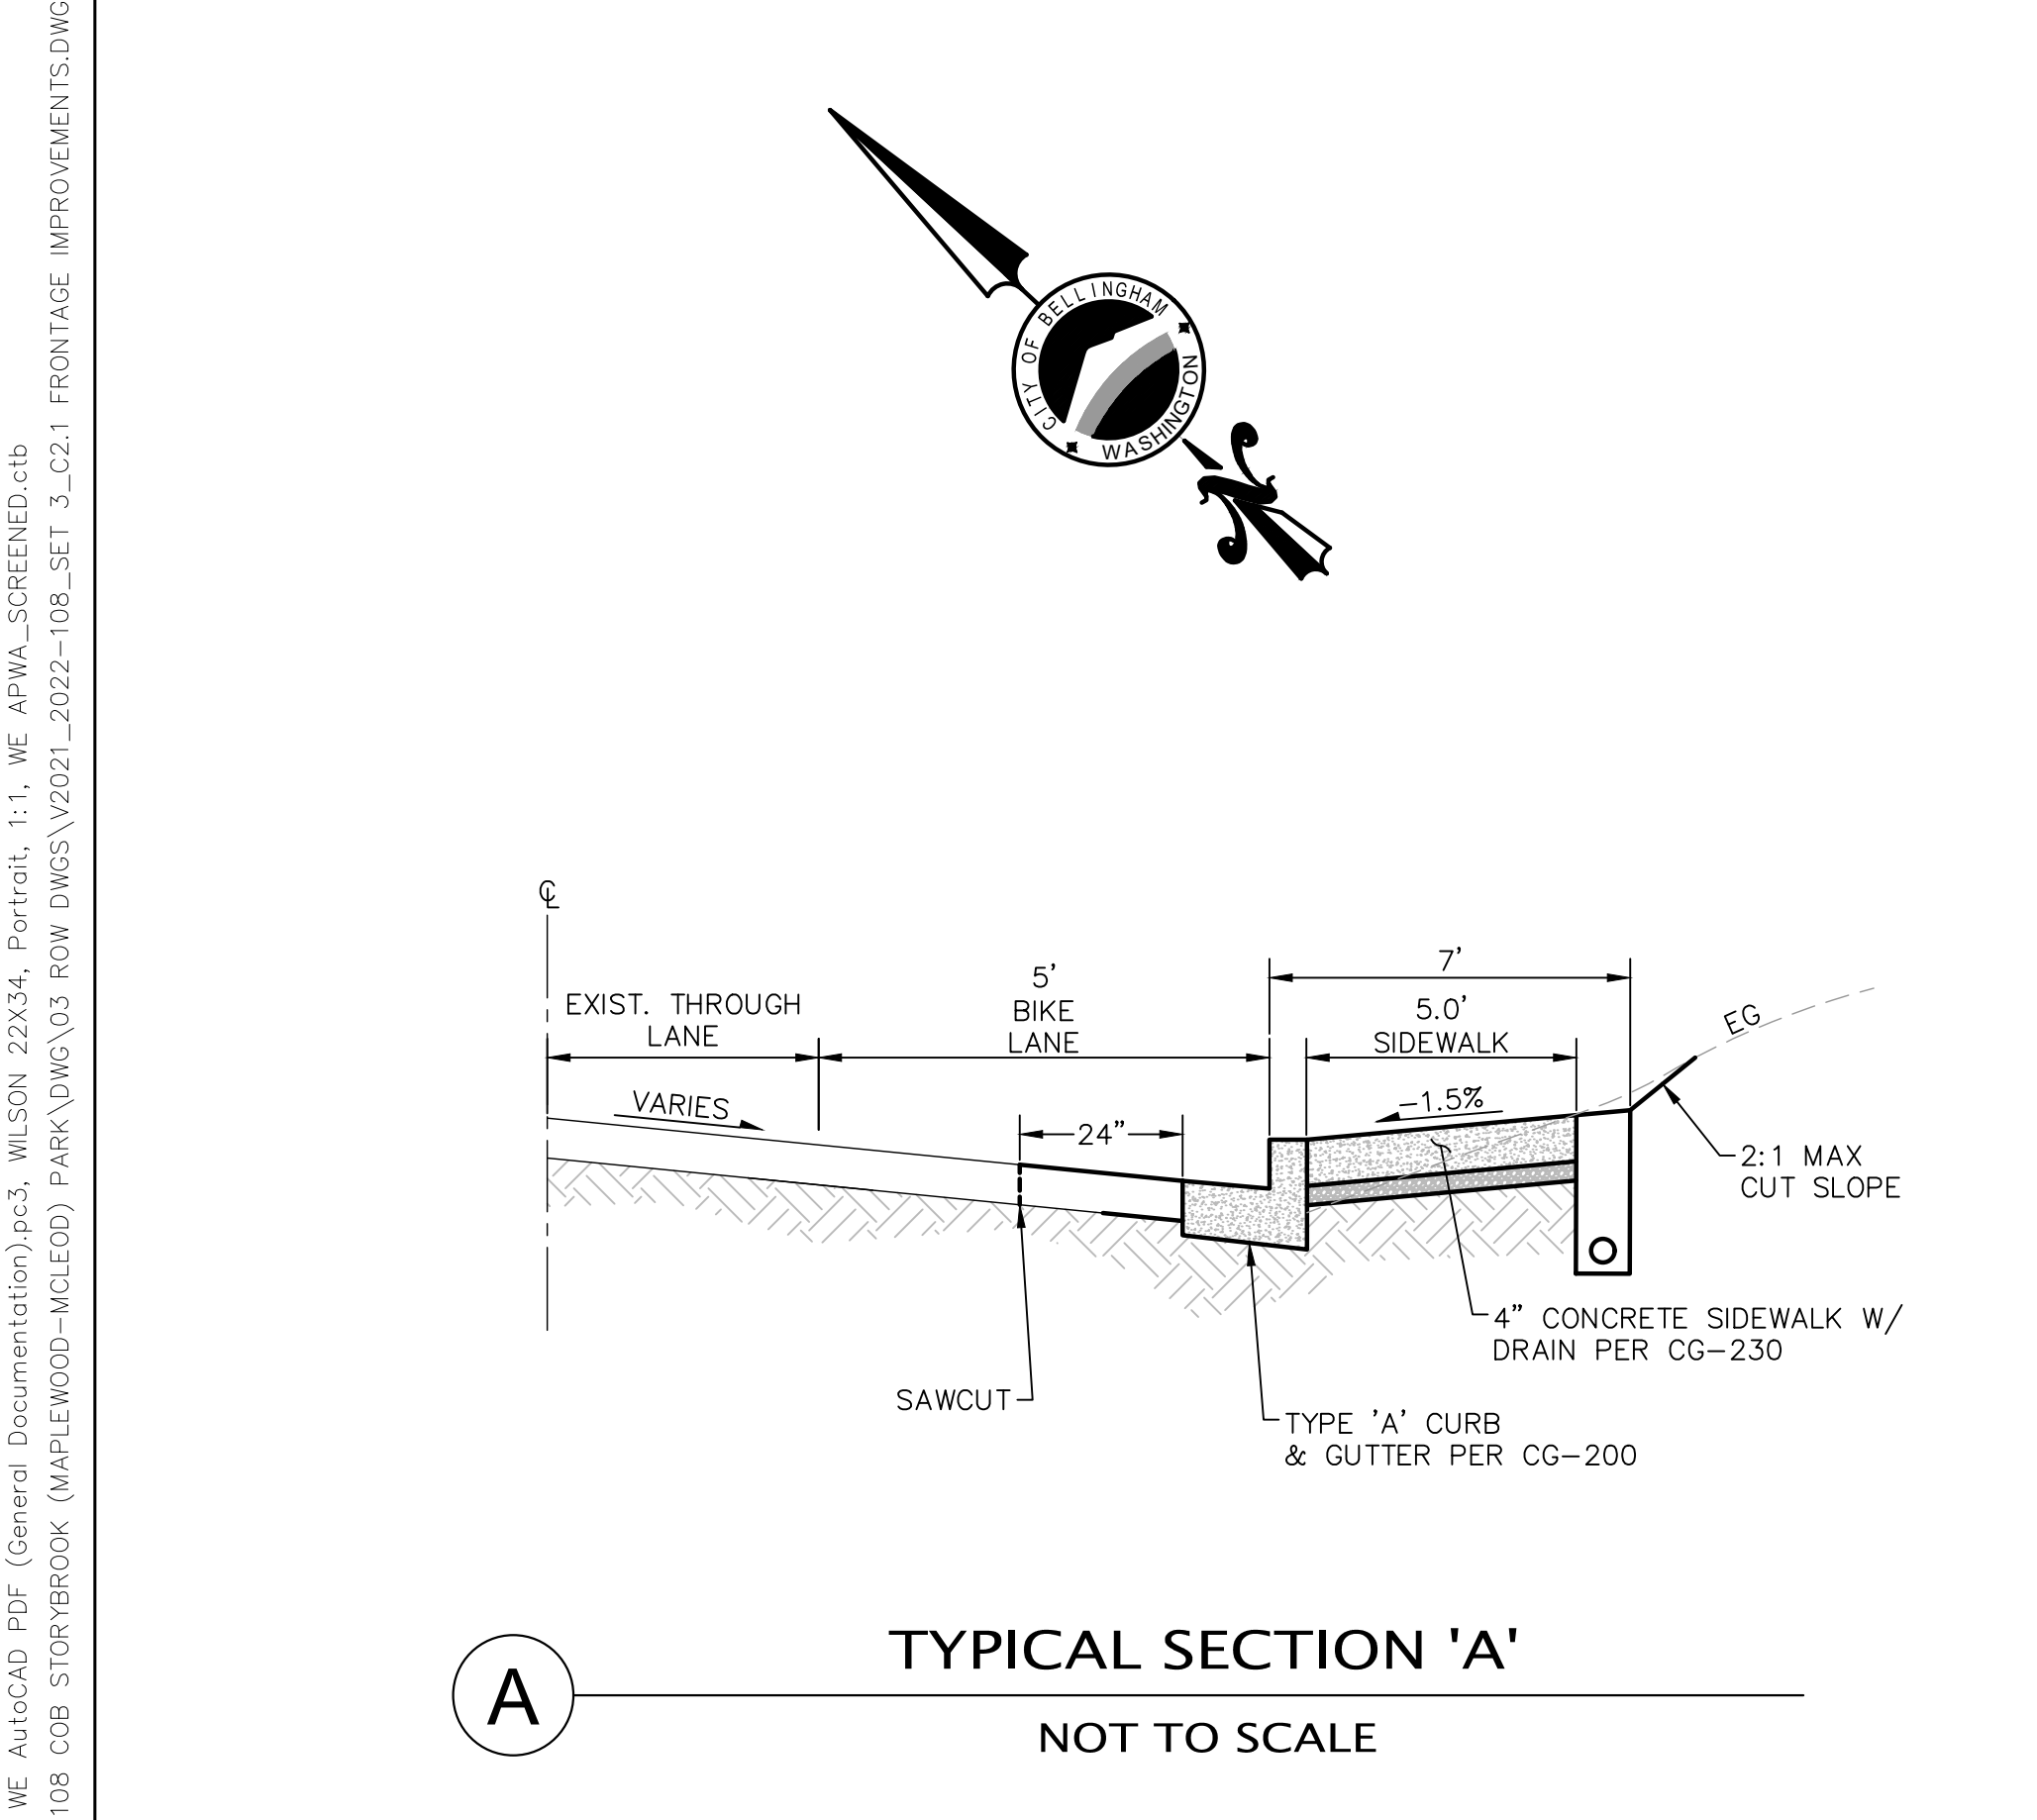

MATCHLINE - SEE ABOVE RIGHT



30% DESIGN

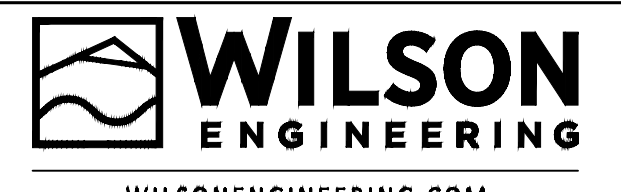

Date	No	Revision	By
	4		
	3		
	2		
	1		

PROJECT ENGINEER	DJ
DESIGNED/DRAWN	PMT/JGS
INSPECTOR	XXX

DIRECTOR PUBLIC WORKS	ECJ
CITY ENGINEER	-
ASSISTANT DIRECTOR	-

CITY OF BELLINGHAM, WASHINGTON
PUBLIC WORKS DEPARTMENT
ENGINEERING DIVISION

SCALE
Horiz. As Shown
Vert. As Shown

DATUM
H: NAD 83/98
V: NAVD 88

Job. No. --
Date 3/24/2023
Field Bk.

WEST MAPLEWOOD AVENUE SIDEWALK IMPROVEMENTS
FRONTAGE IMPROVEMENTS SITE PLAN

DRAWING NO.
C2.1
SHEET NO.
6 OF 6

CONTACT PERSON: _____

PLOT SETTINGS: WE AutoCAD PDF (General Documentation).pc3; WILSON 22X34; Portrait; 1:1; WE APWA_SCREENED.ctb
W:\2022\2022-108 COB STORYBROOK (MAPLEWOOD-MCLEOD) PARK\DWG\03 ROW DWGS\2021_2022-108_SET 3_C2.1 FRONTAGE IMPROVEMENTS.DWG - 3/23/2023 3:08 PM - Jeff Smith